



TYPE 3

House Unit Type:
C2, D2


TYPE 3

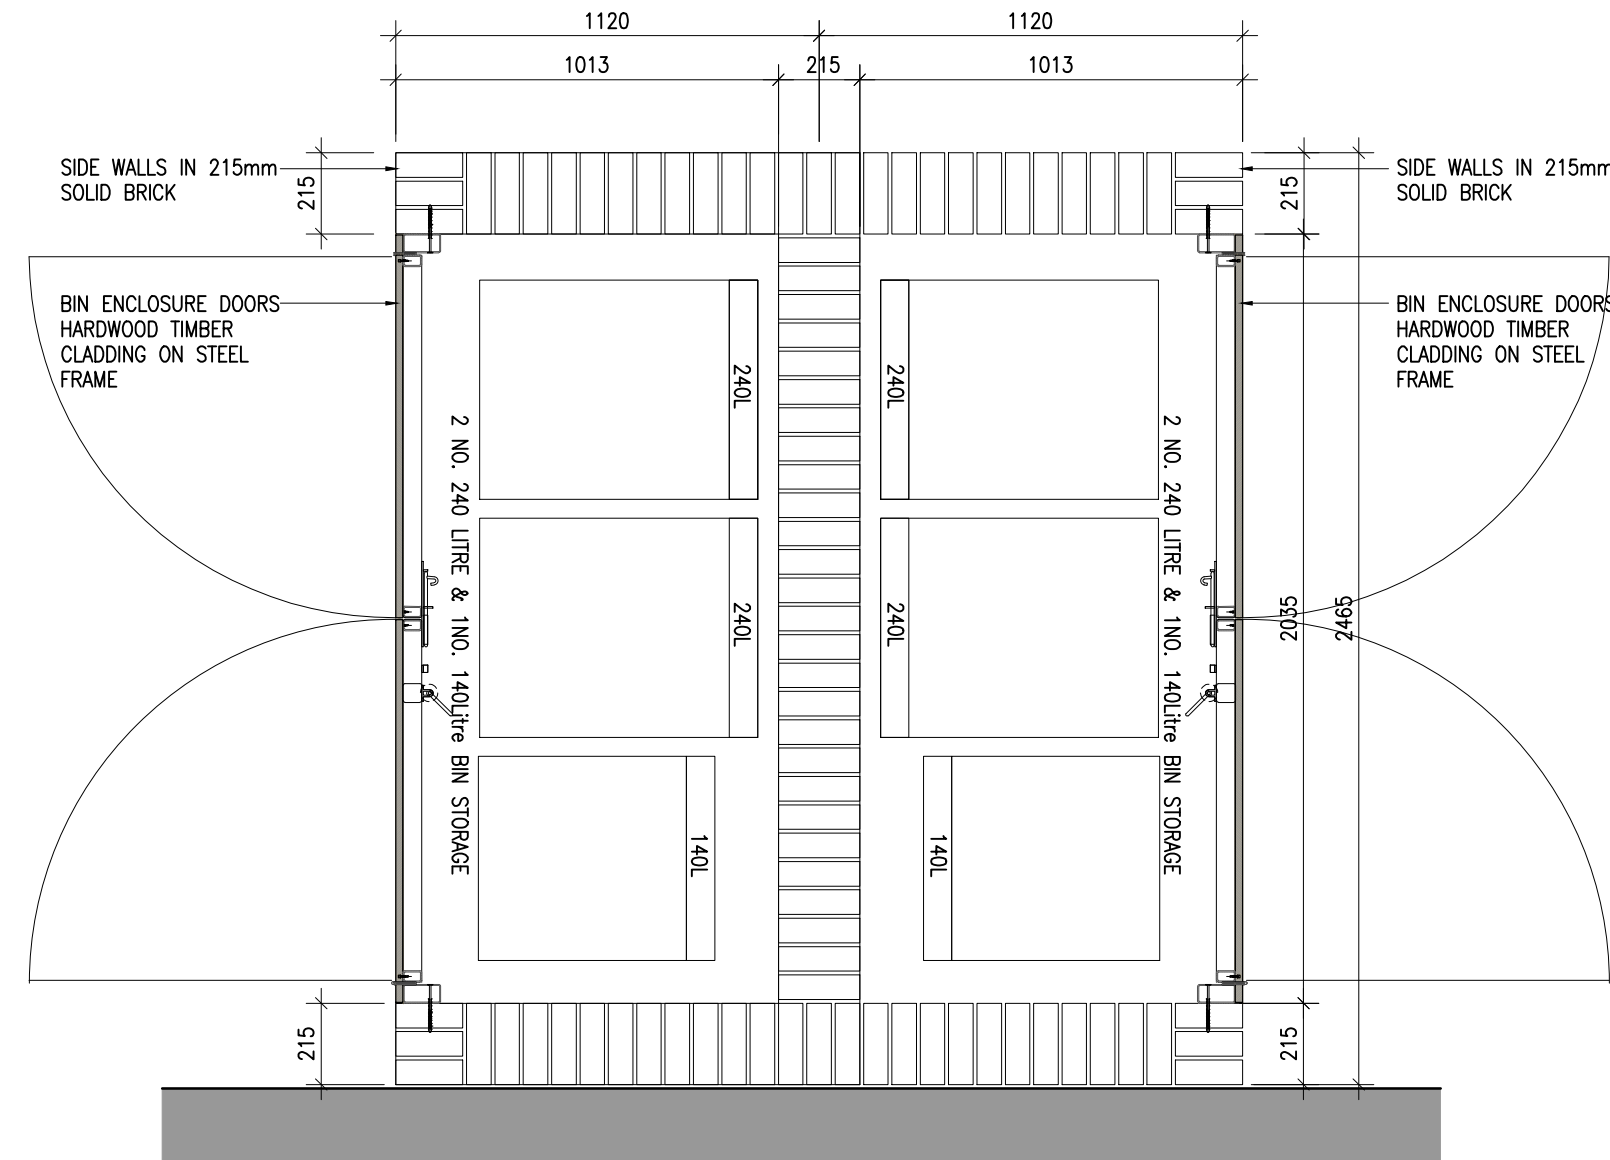


1 Bin store Type 3 Plan
Scale 1:20

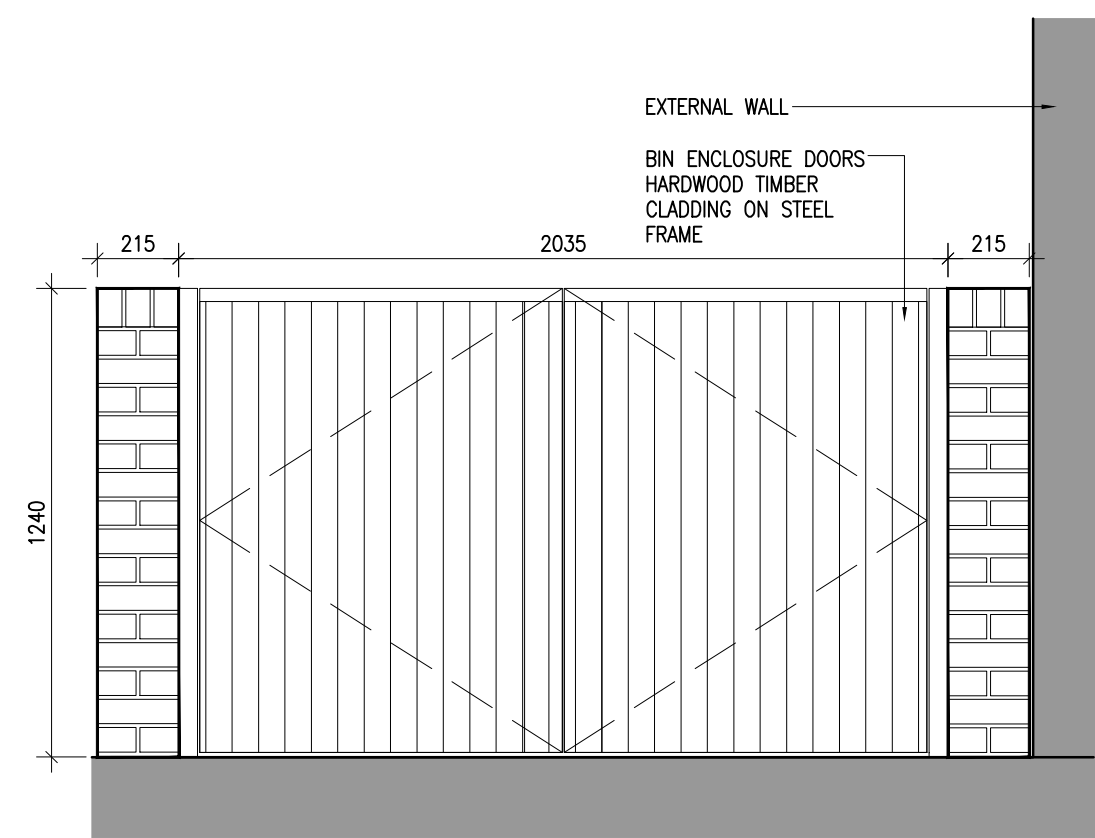

2 Bin store Type 3 Side Elevation
Scale 1:20

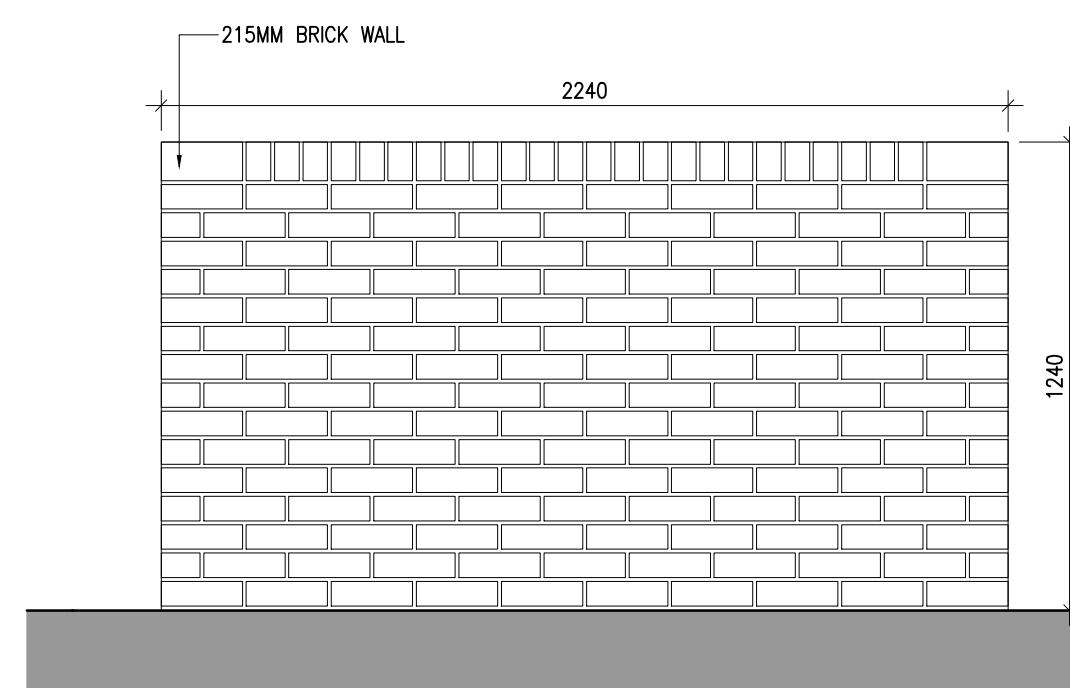


3 Bin store Type 3 Front
Scale 1:20

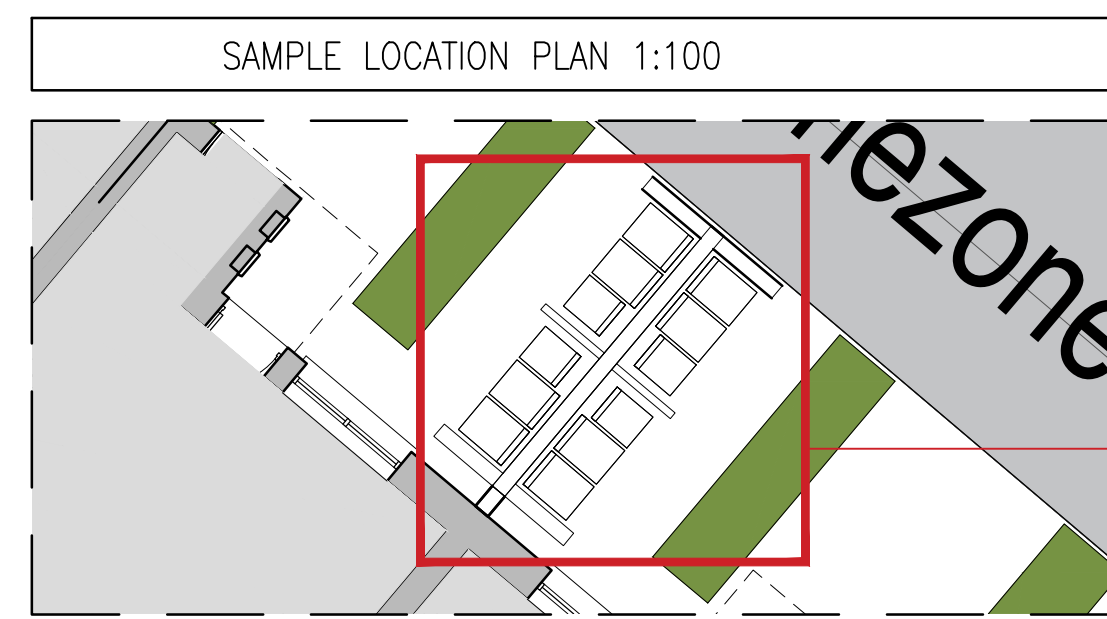


TYPE 4

Duplex Type:
L/M


TYPE 4

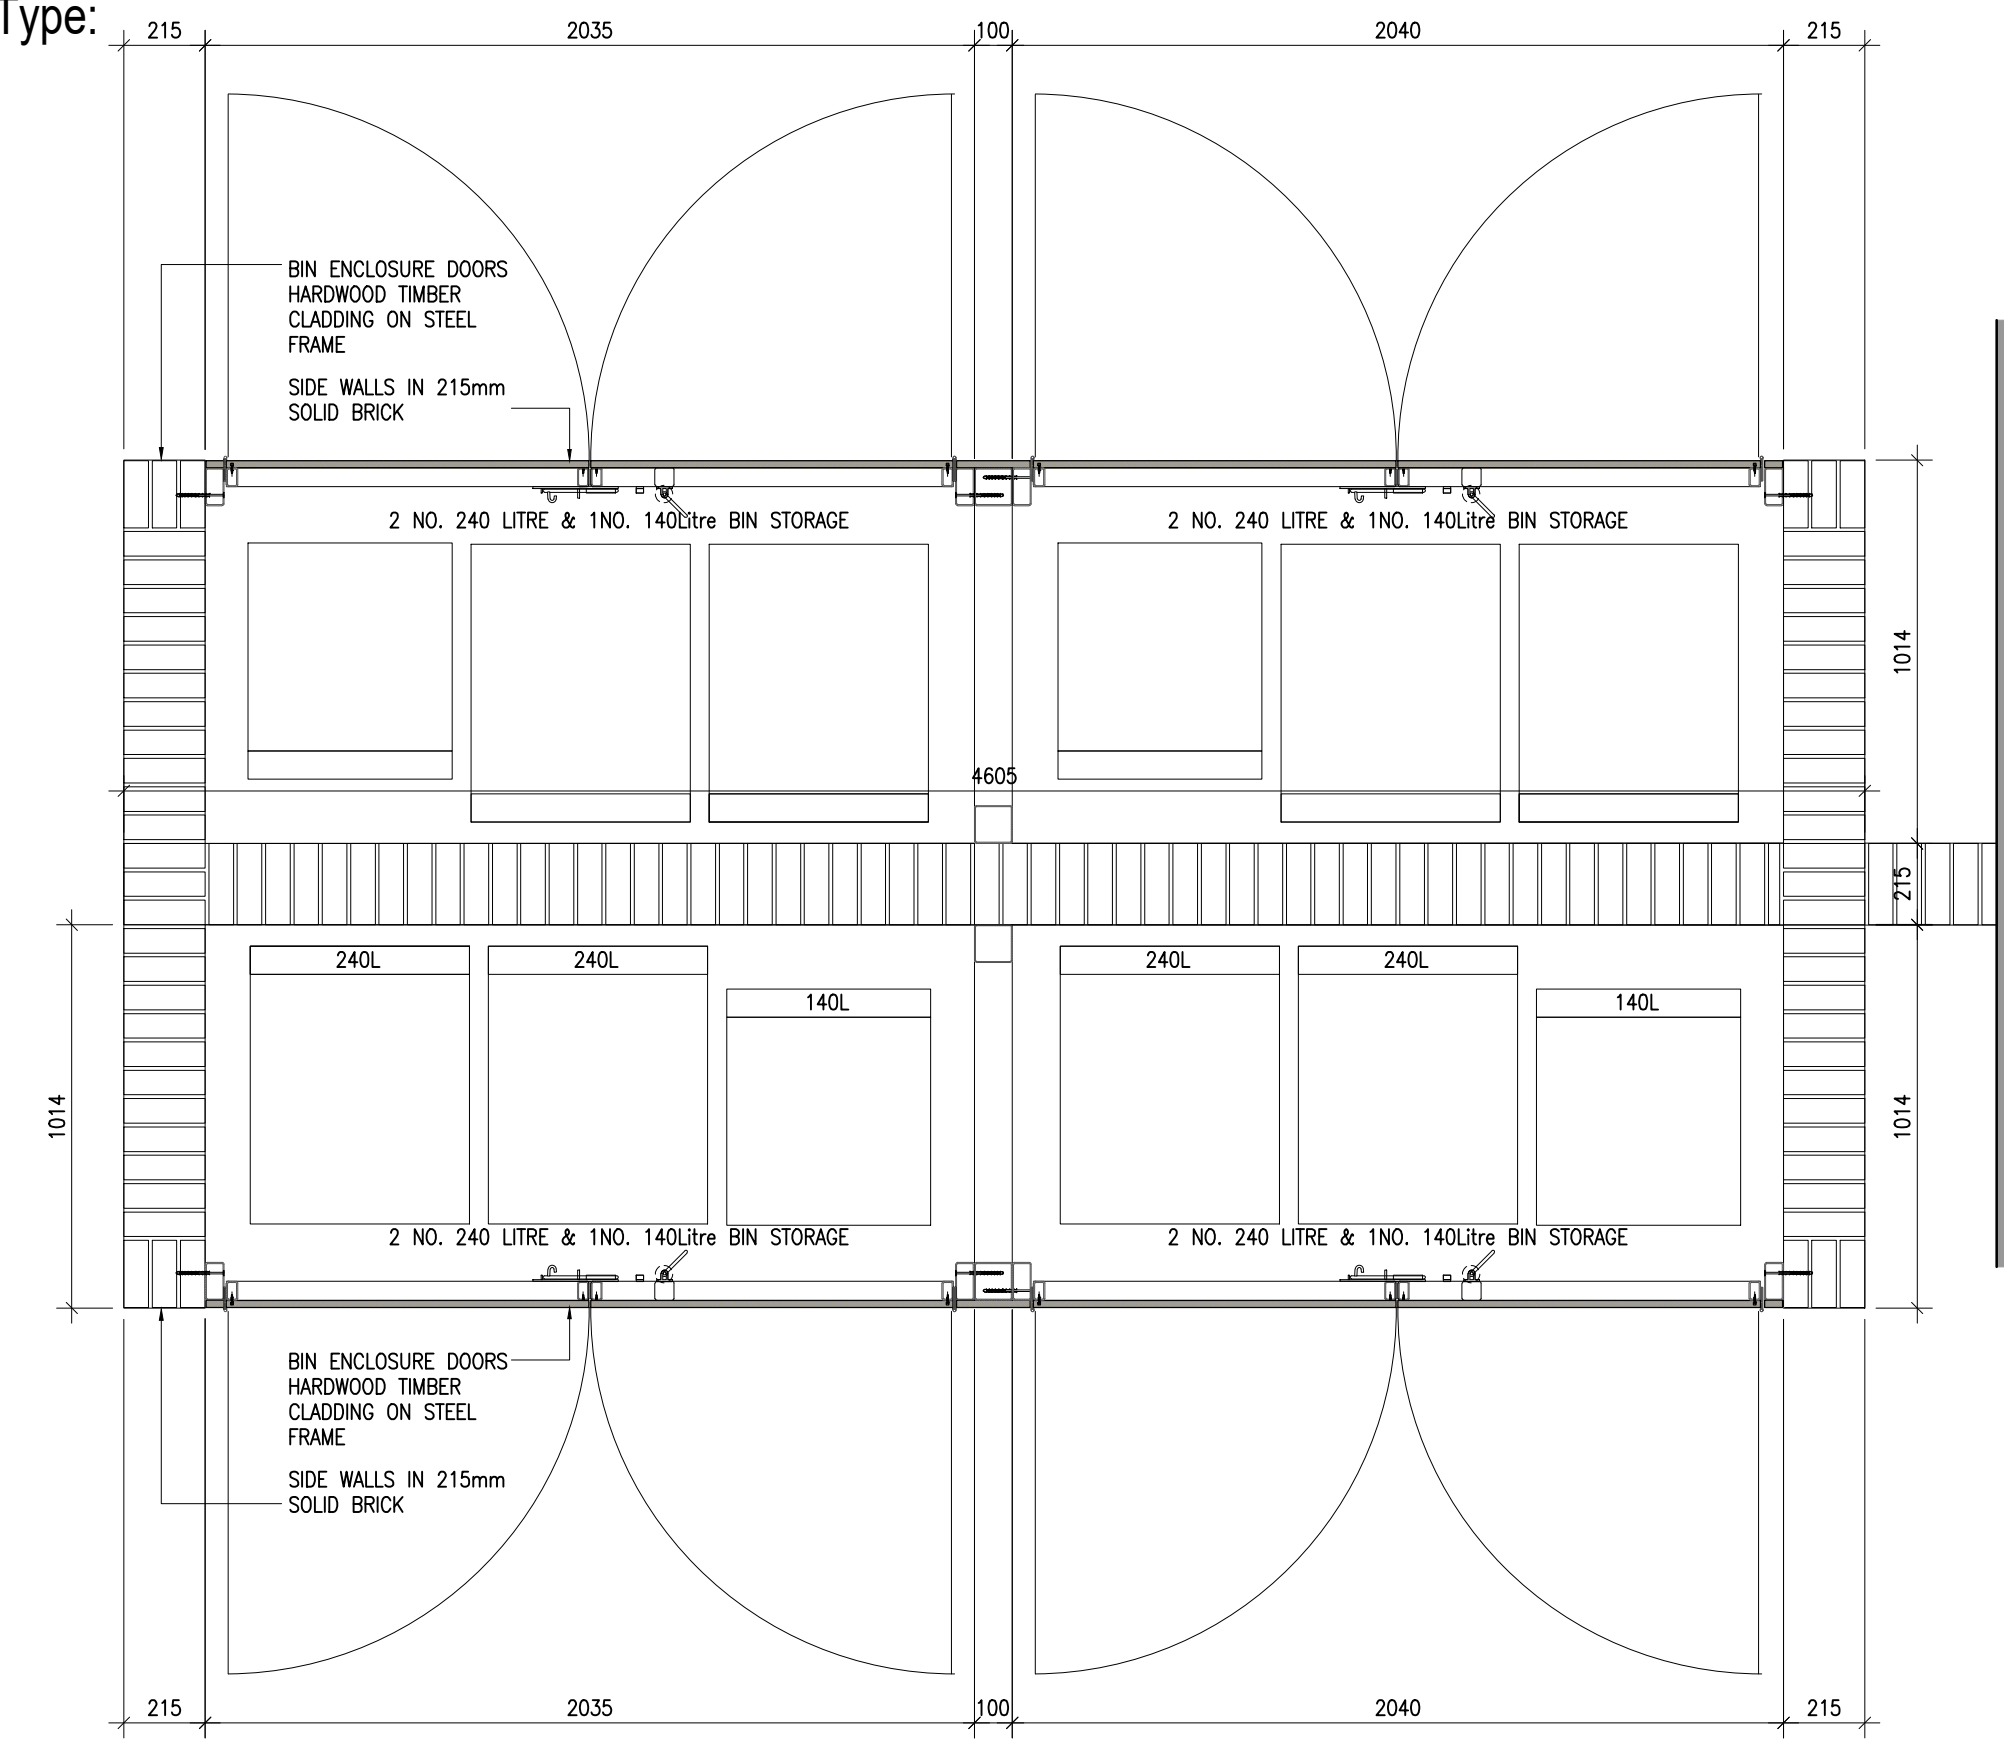


5 Bin store Type 4 Plan
Scale 1:20

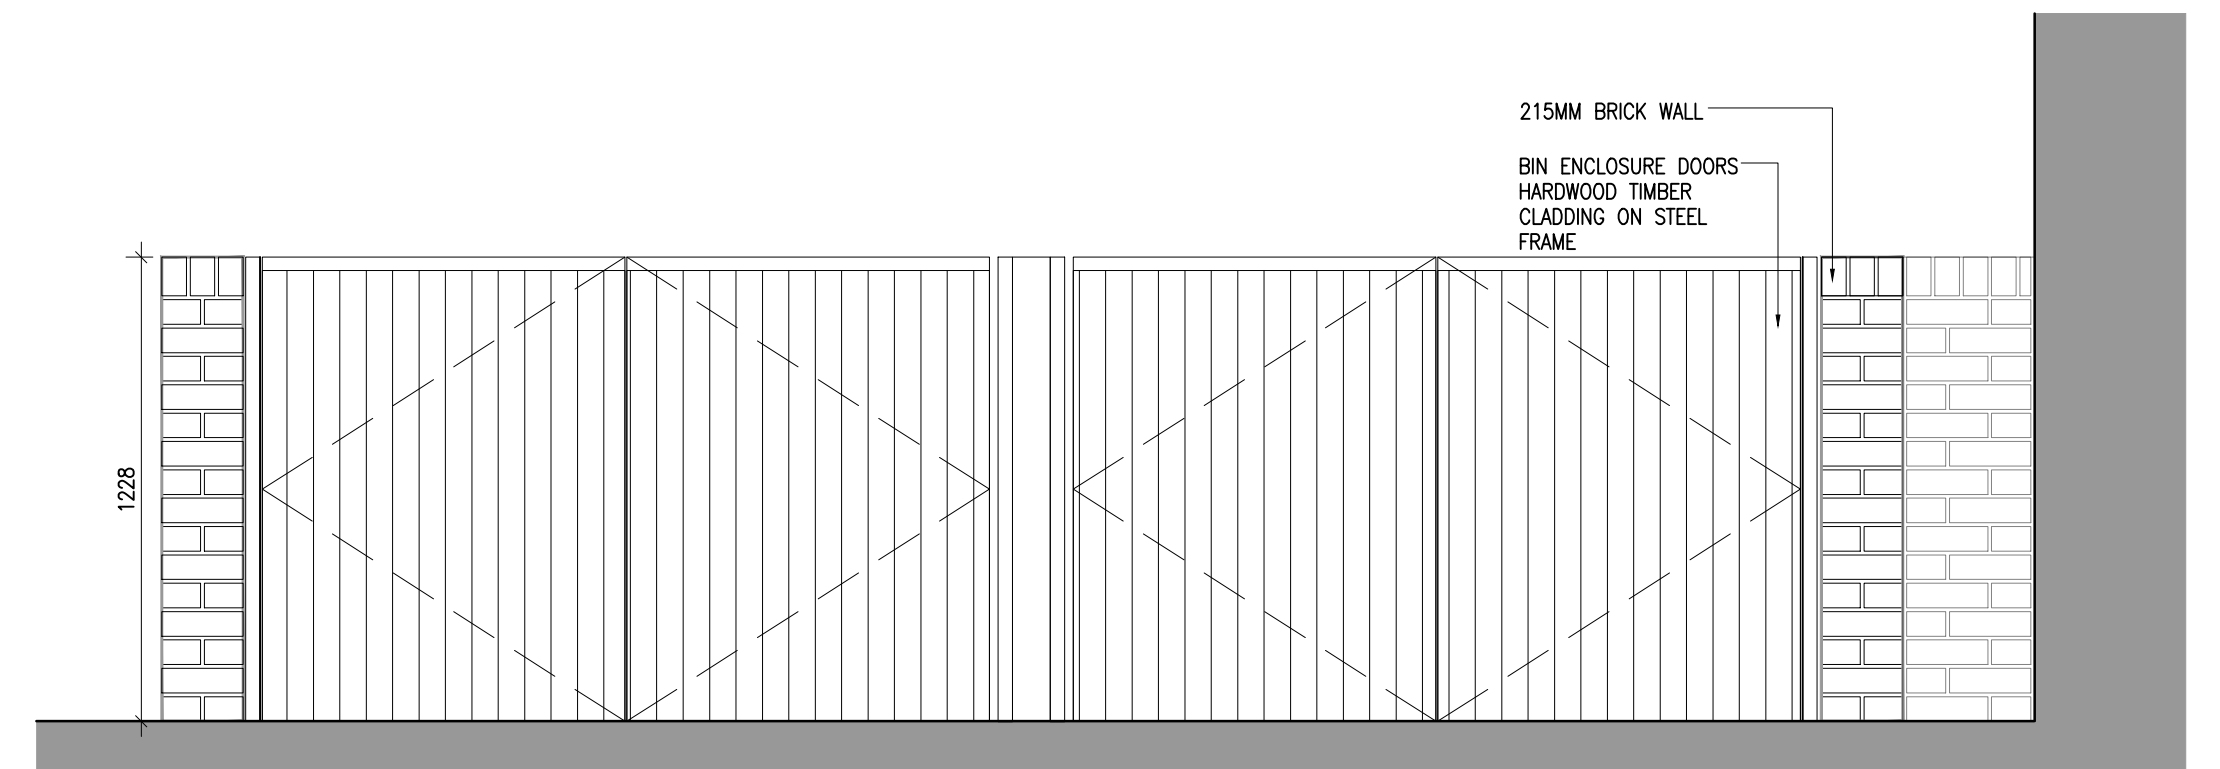

6 Bin store Type 4 Front Elevation
Scale 1:20

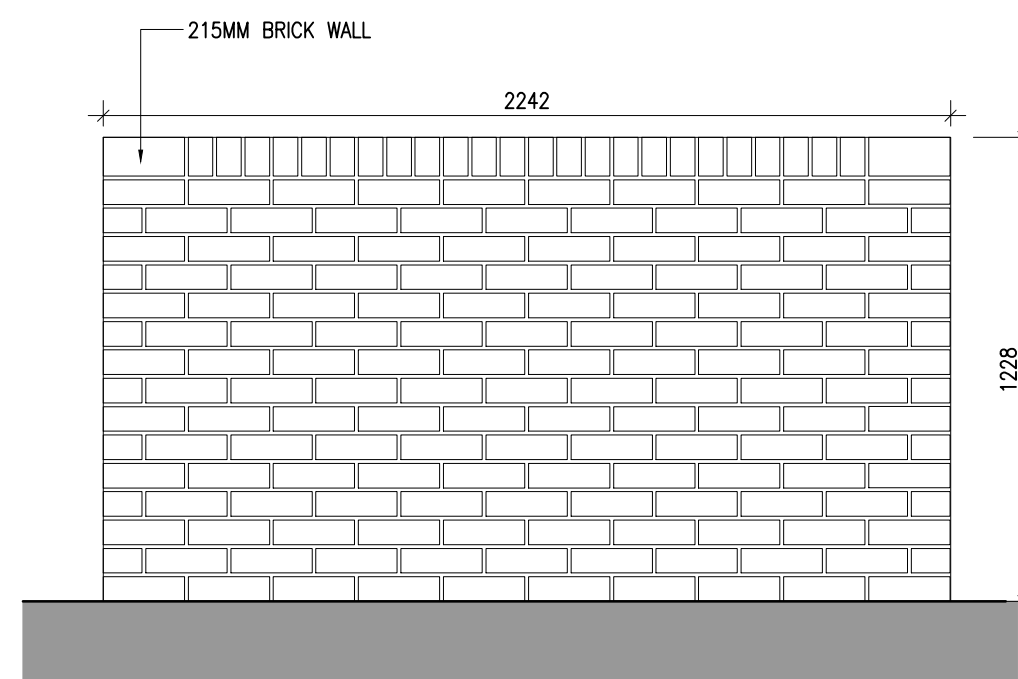

7 Bin store Type 4 Side Elevation
Scale 1:20

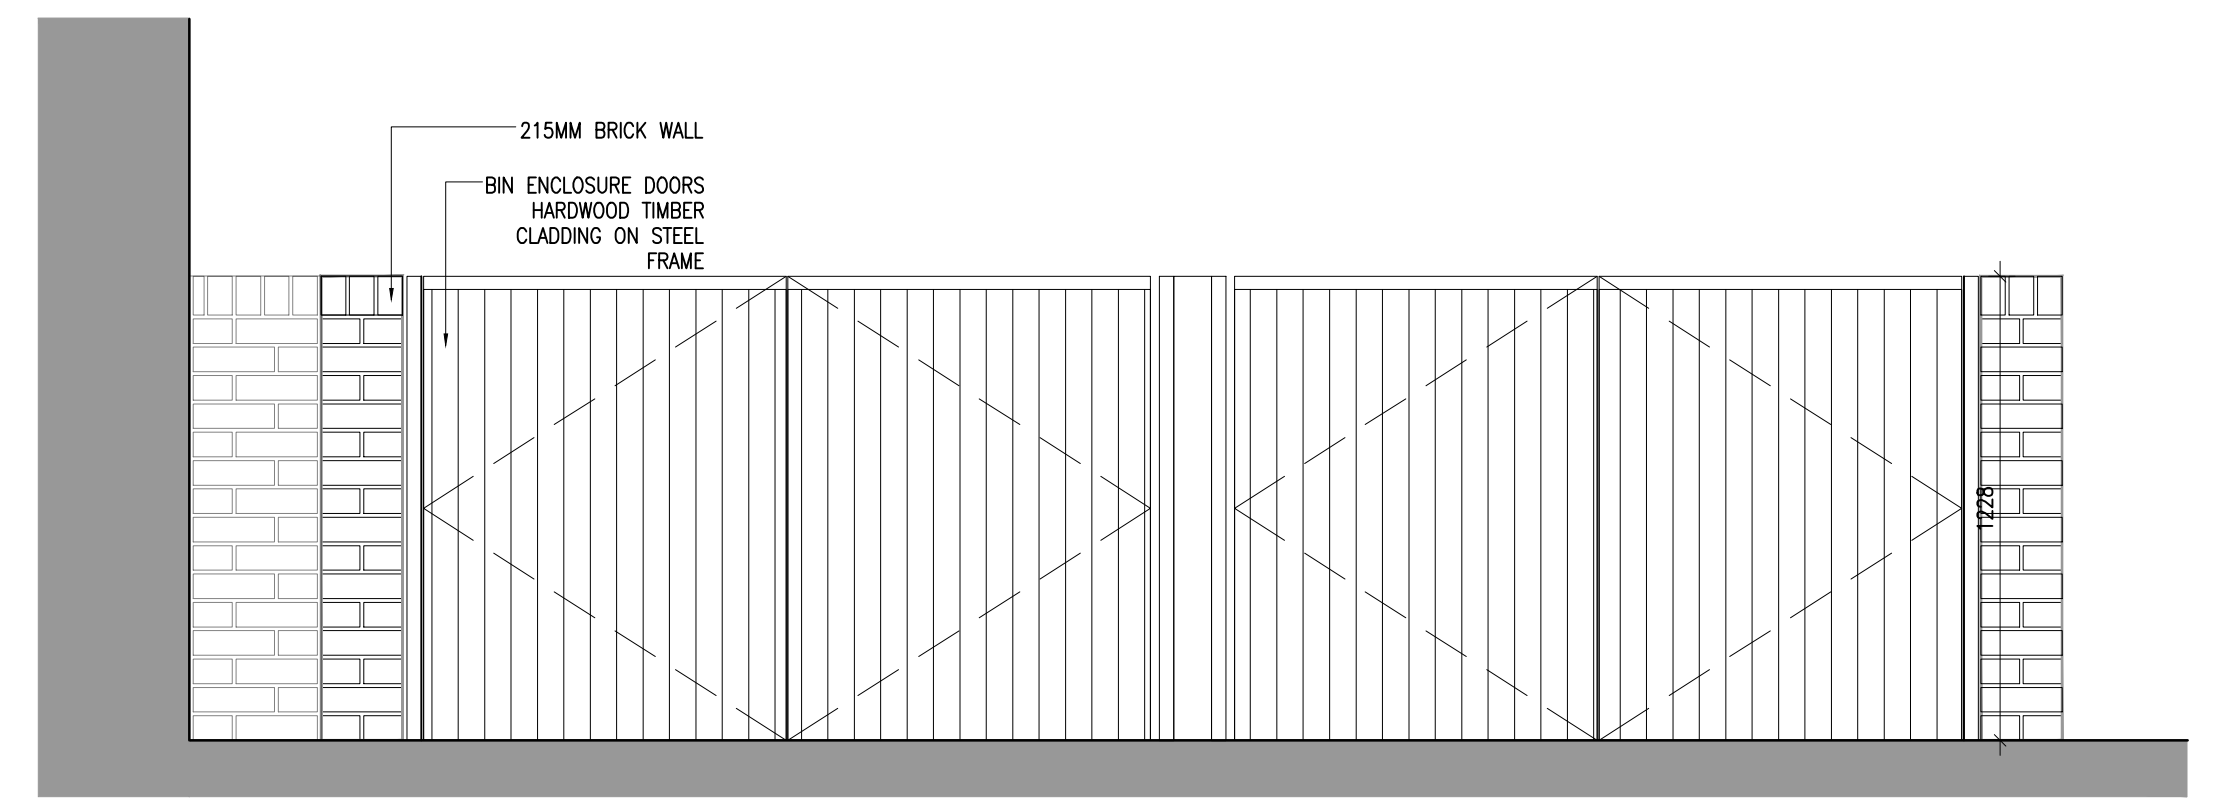

8 Bin store Type 4 Rear Elevation
Scale 1:20

Notes	Issue Status
1. Copyright Reserved	Progress
2. Work to ignore dimensions only. Do not scale drawing	Planning Application
3. The contractor is responsible for checking all levels and dimensions on site and shall refer all discrepancies to the Architect	Fire Cert
4. Where appropriate, for details of r.c. structure, or mechanical and electrical details, see Engineers drawings	Disability Cert
5. Proprietary items shall be fixed in strict accordance with manufacturers instructions.	Tender
6. Sizes of proprietary items shall be checked with manufacturer.	Construction
7. The contractor shall be responsible for the coordination of structure, finishes and services.	As Built
	Information Only

No.	Date	Revision	Initials
01	27.06.2022	SHD PLANNING APPLICATION	SH

Project	Residential Development at Rathgowan, Mullingar for DSPL Ltd
Drawing Title	Bin store Details Type 3,4
Drawing No	6253-P-411
Scale	1:20@A1
Rev	01
Drawn	SH
Date	June 2022

6-7 HARDCOURT TERRACE, DUBLIN 2, IRELAND
t: +353-1-478 2400 f: +353-1-478 7396
www.bkd.ie

bkdarchitects
BURKE-KENNEDY DOYLE